 


OVERALL WATER SYSTEM PLAN
1" = 100'-0"

- LEGEND**
- EXISTING WATER
 - PROPOSED WATER (TO BE CONSTRUCTED BY CITY)
 - PROPOSED POINT OF CONNECTION
 - PROPOSED BUILDING
 - PROPOSED CIVIC SPACE
 - PROPOSED PAVEMENT



Project:
Union Square Redevelopment
Union Square, Somerville, MA

PREPARED BY:
 Stantec
226 CAUSEWAY STREET
BOSTON, MA 02114
617.523.8103

PREPARED FOR:
 US²
UNION SQUARE
STATION
ASSOCIATES

PROJECT NORTH

SOMERVILLE USE ONLY

Permit-Seal


CDSP SUBMISSION	By	Appd	YYYY.MM.DD
Issued/Revision			
Title			

OVERALL WATER SYSTEM PLAN

Project No. 179801783
Scale 1" = 100'-0"
Drawing No.


C-102

ORIGINAL SHEET - ARCH D

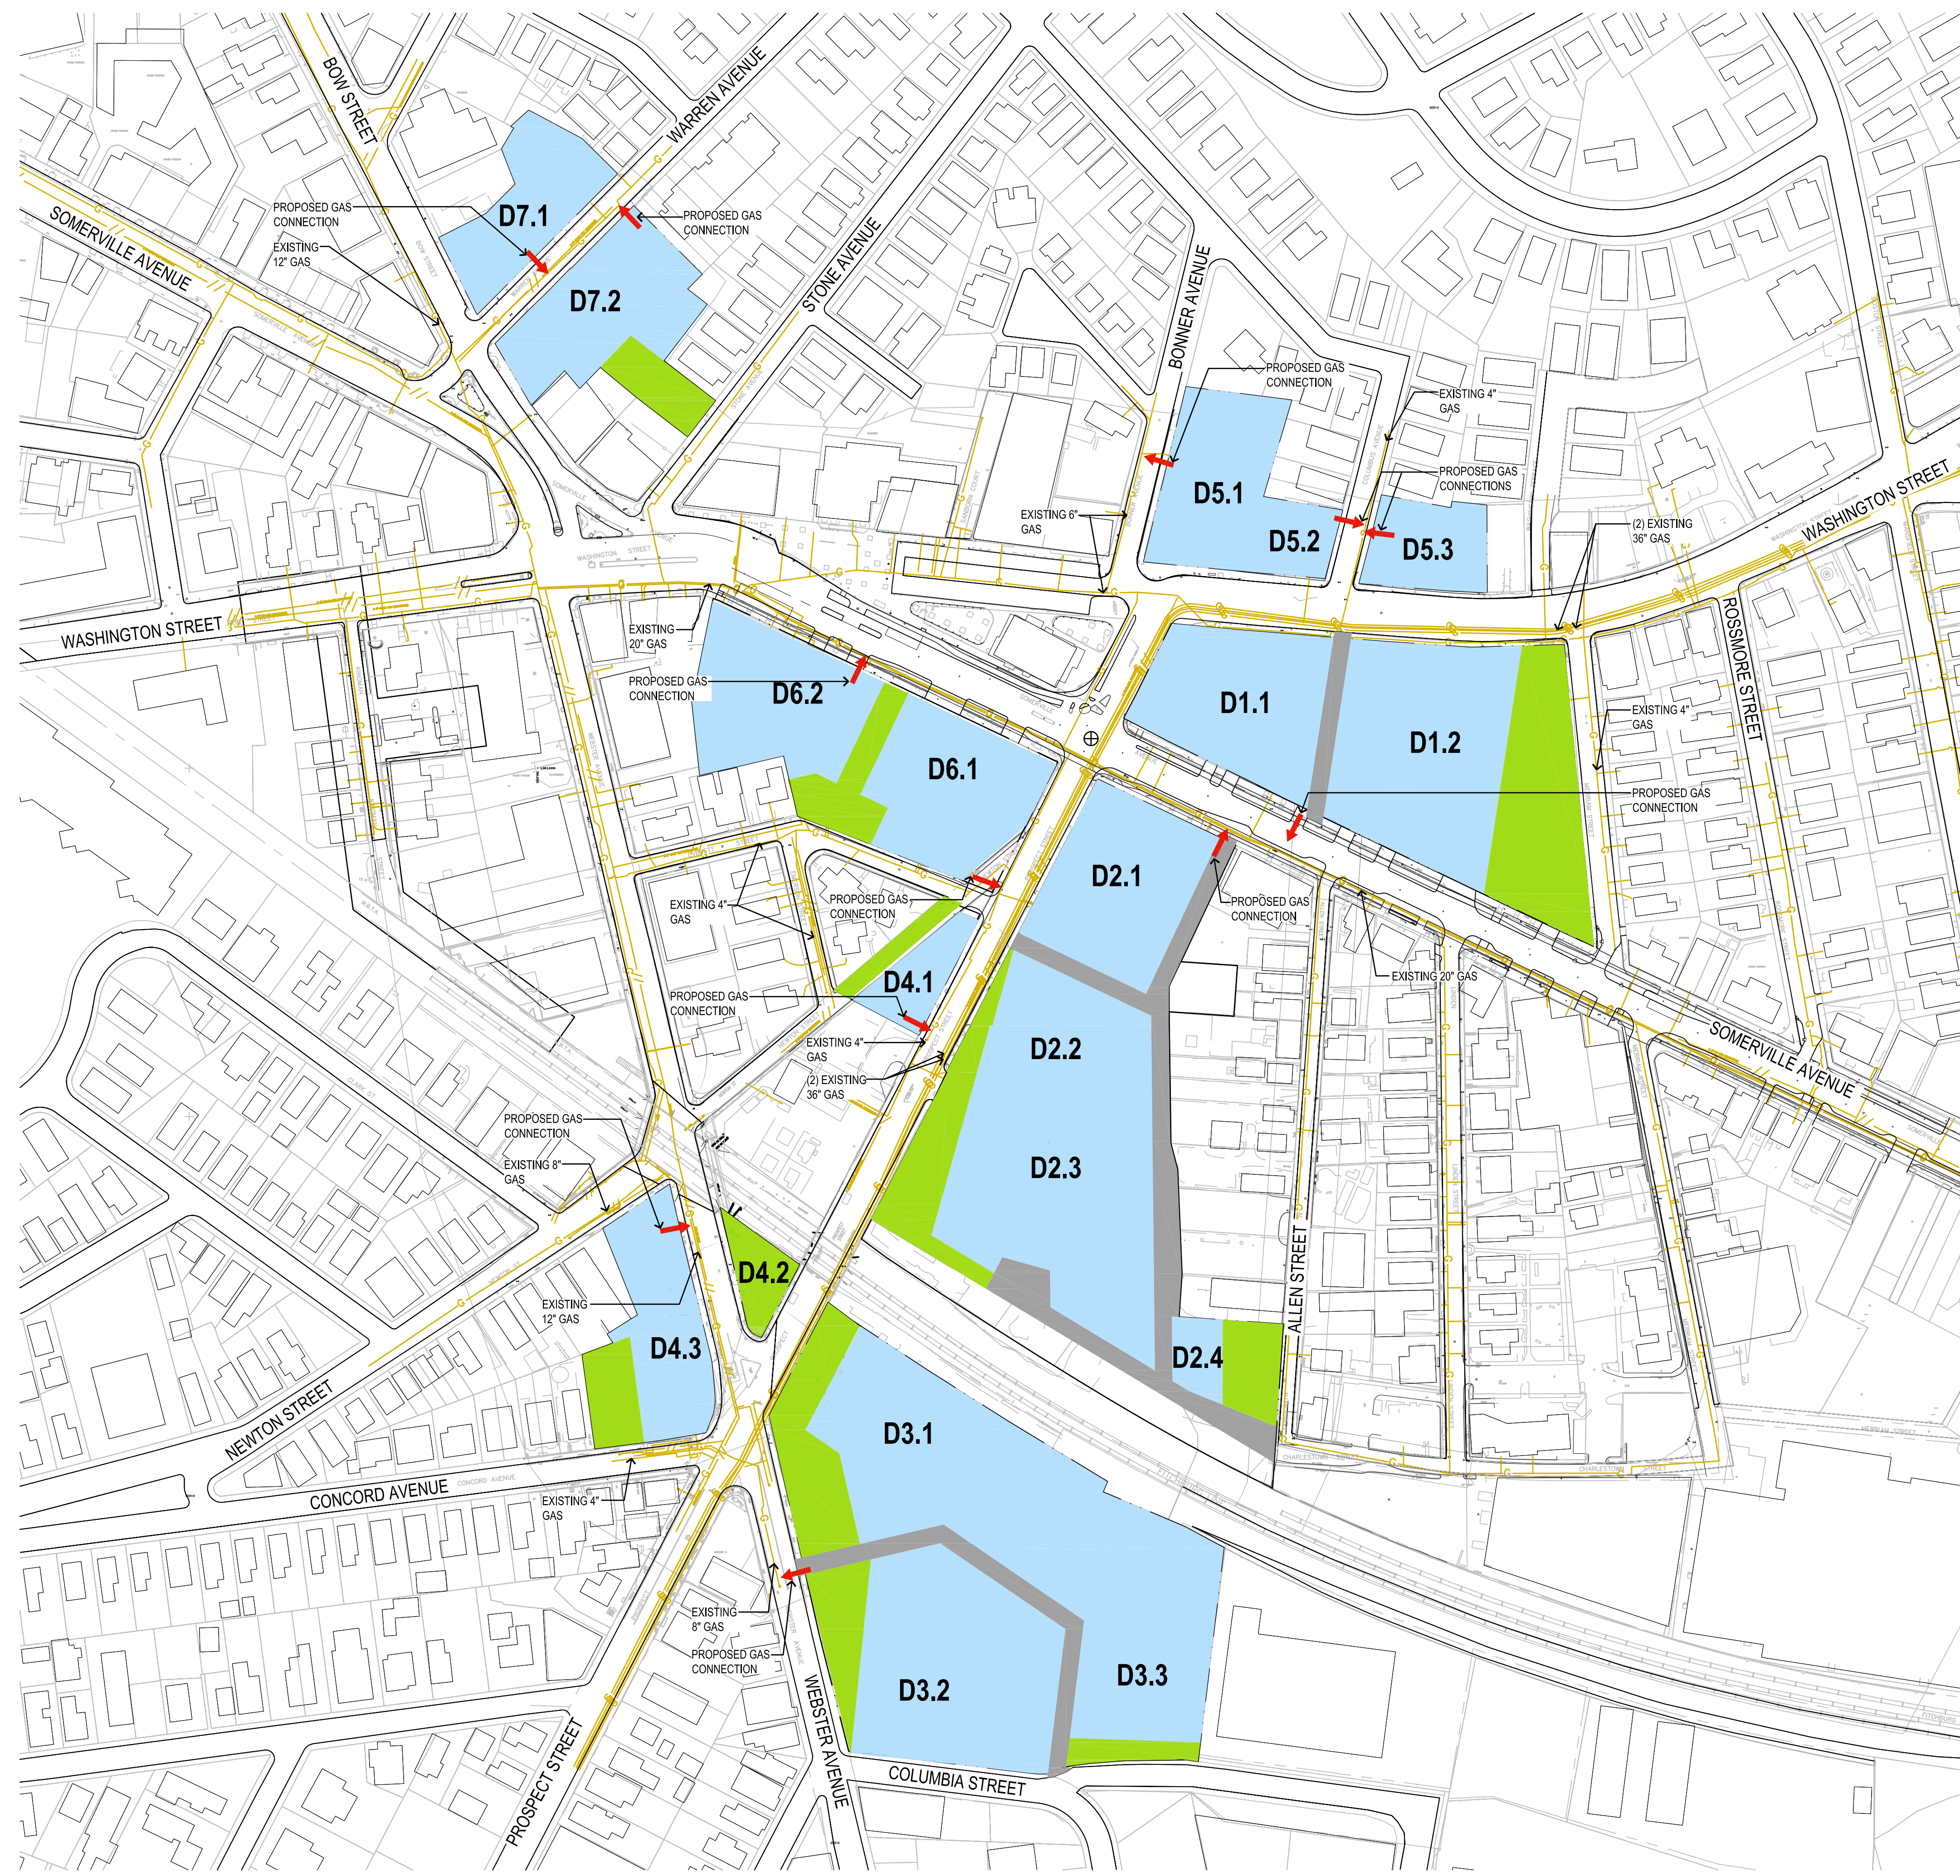

OVERALL GAS PLAN
1" = 100'-0"

 - LEGEND**
- EXISTING GAS
 - PROPOSED POINT OF CONNECTION
 - PROPOSED BUILDING
 - PROPOSED CIVIC SPACE
 - PROPOSED PAVEMENT



Project:
Union Square Redevelopment
Union Square, Somerville, MA

PREPARED BY:
 Stantec
226 CAUSEWAY STREET
BOSTON, MA 02114
617.523.8103

PREPARED FOR:
 US²
UNION SQUARE
STATION
ASSOCIATES

PROJECT NORTH

SOMERVILLE USE ONLY


Permit-Seal

CDSP SUBMISSION		FH	
Issue/Revision	By	Appd	YYYY.MM.DD
Title			
OVERALL GAS PLAN			

Project No. 179801783
Scale 1" = 100'-0"
Drawing No.


C-103

ORIGINAL SHEET - ARCH D

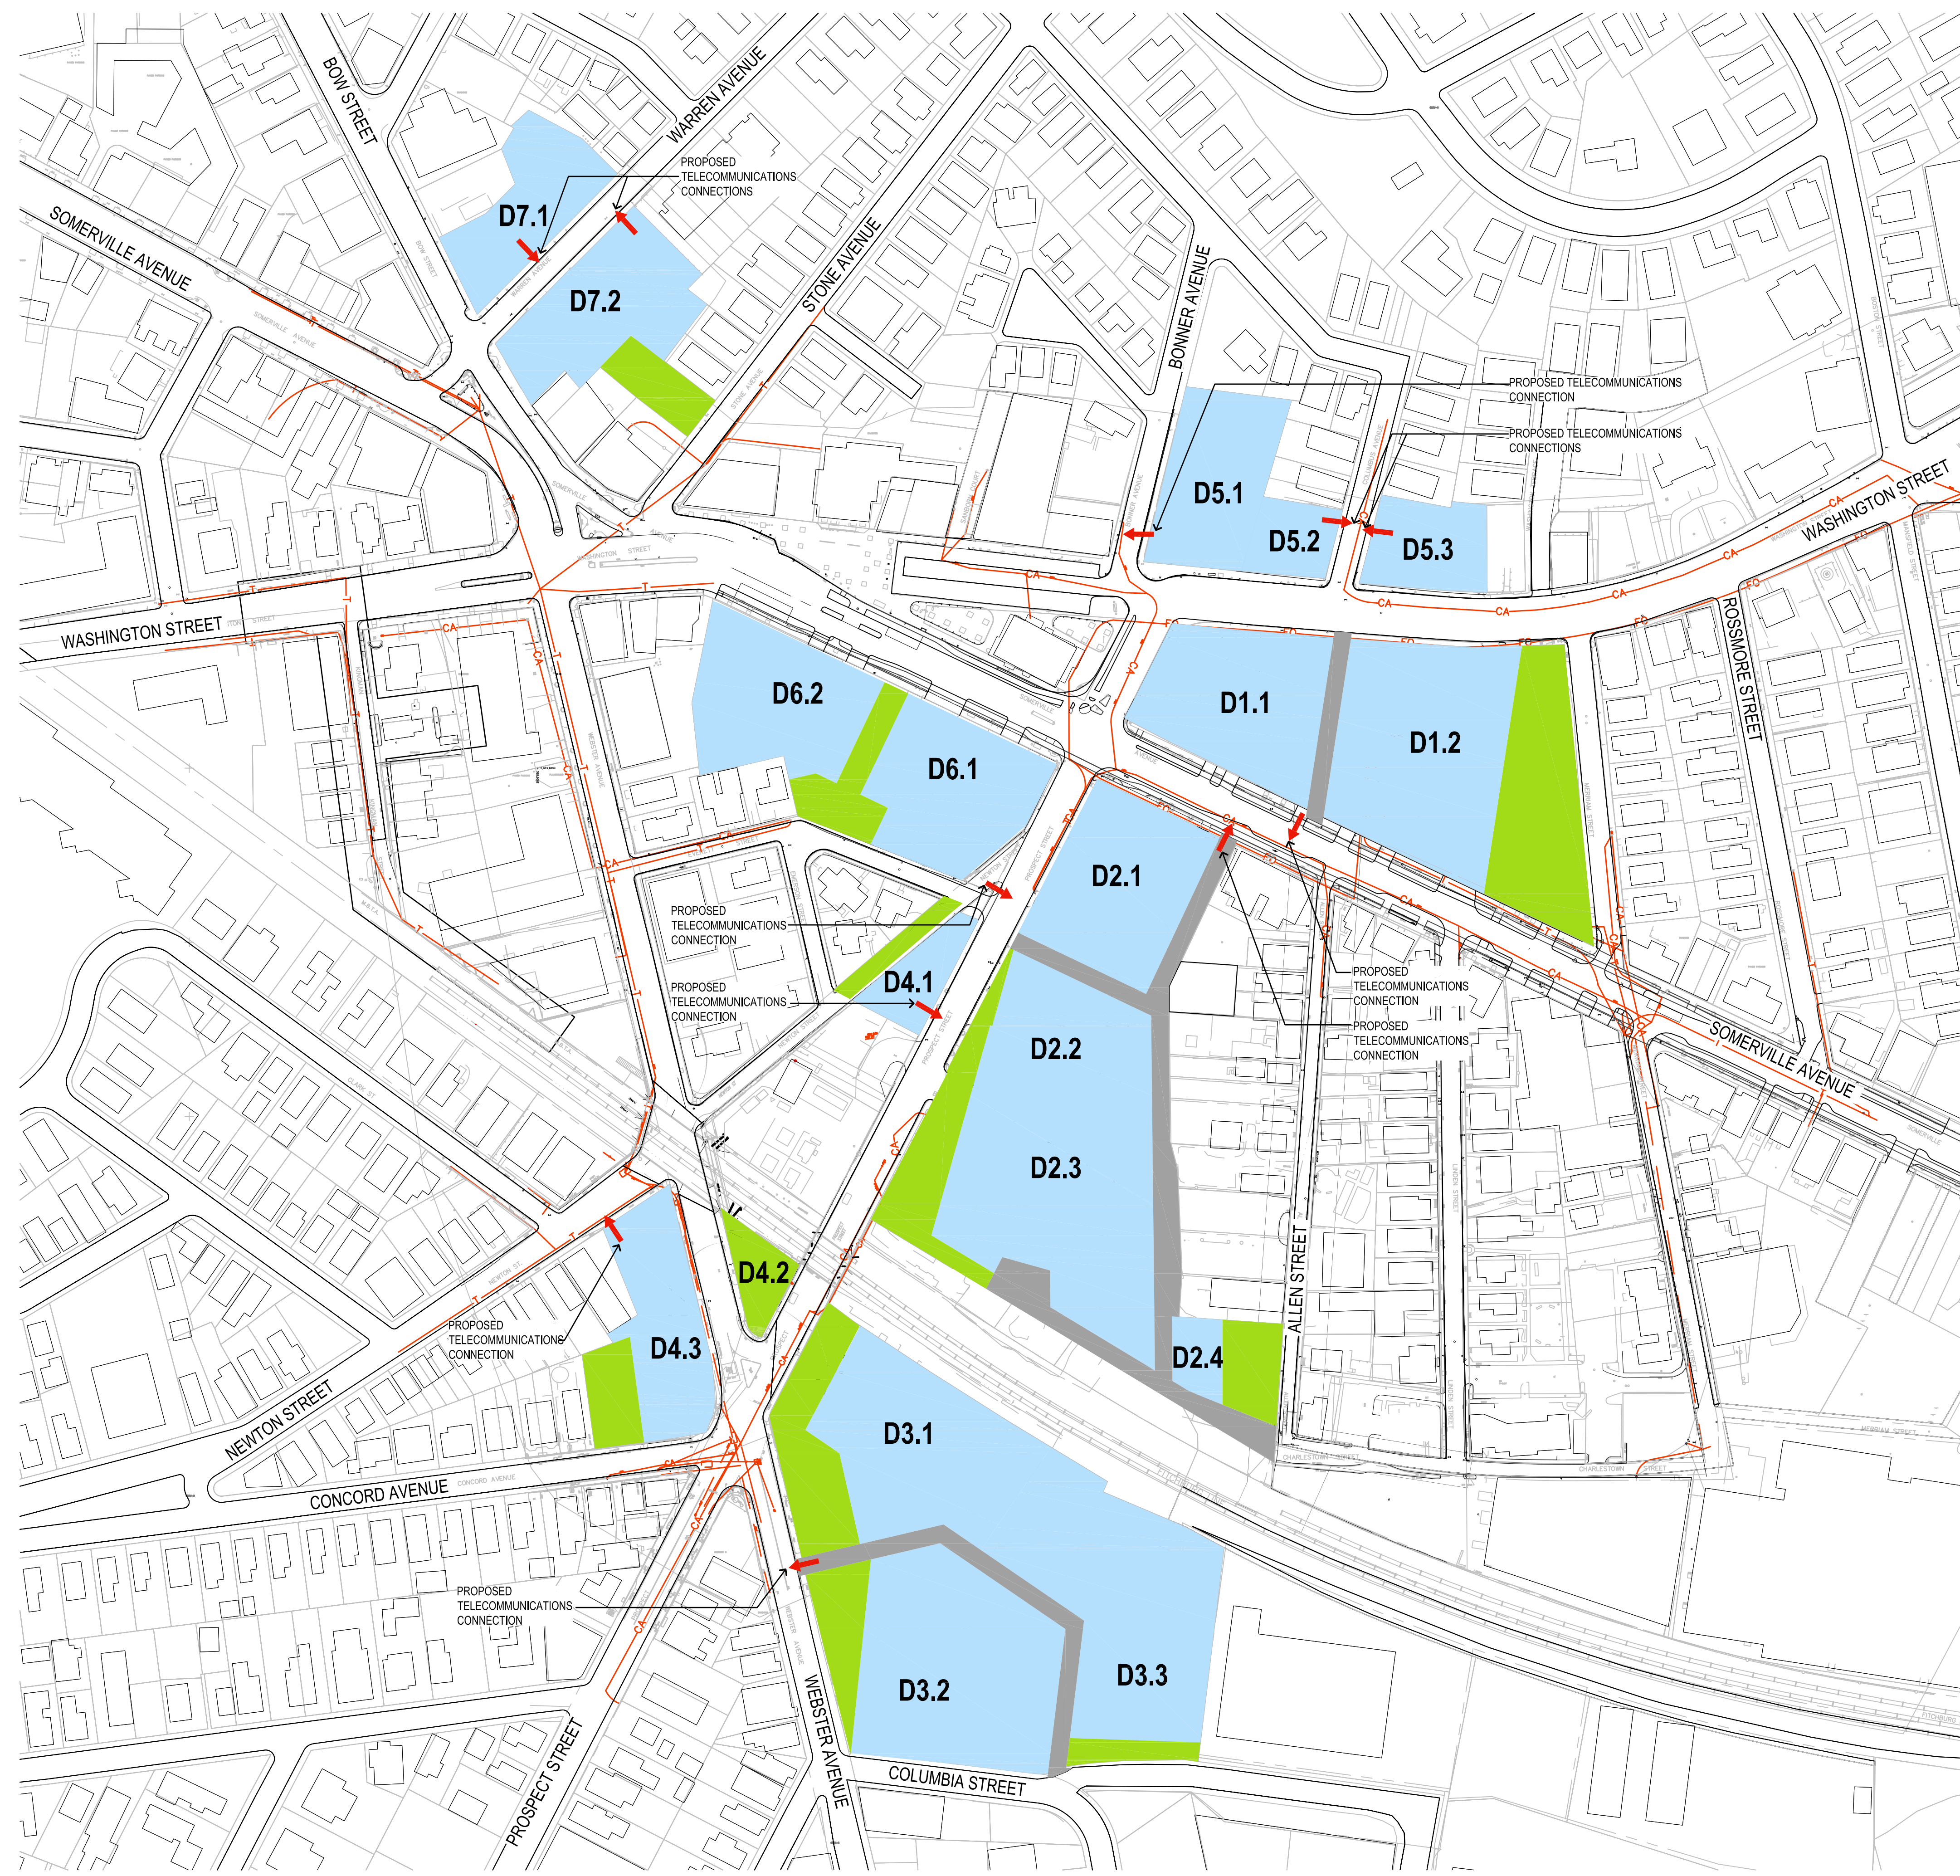

OVERALL TELECOMMUNICATION PLAN
1" = 100'-0"

 - LEGEND**
- CA EXISTING TELECOMMUNICATIONS
 - PROPOSED POINT OF CONNECTION
 - PROPOSED BUILDING
 - PROPOSED CIVIC SPACE
 - PROPOSED PAVEMENT



Project:
Union Square Redevelopment
Union Square, Somerville, MA

PREPARED BY:
Stantec
226 CAUSEWAY STREET
BOSTON, MA 02114
617.523.8103

PREPARED FOR:
US²
UNION SQUARE
STATION
ASSOCIATES

PROJECT NORTH

SOMERVILLE USE ONLY

Permit-Seal

CDSP SUBMISSION	By	Appd	YYYY.MM.DD

OVERALL TELECOMMUNICATION PLAN	
Project No. 179801783	Scale 1" = 100'-0"
Drawing No.	

C-105

ORIGINAL SHEET - ARCH D
 DATE: 11/15/17
 PROJECT: 179801783
 DRAWING: C-105